



SECOND FLOOR SANITARY PLAN
SCALE: 1/4" = 1'-0"

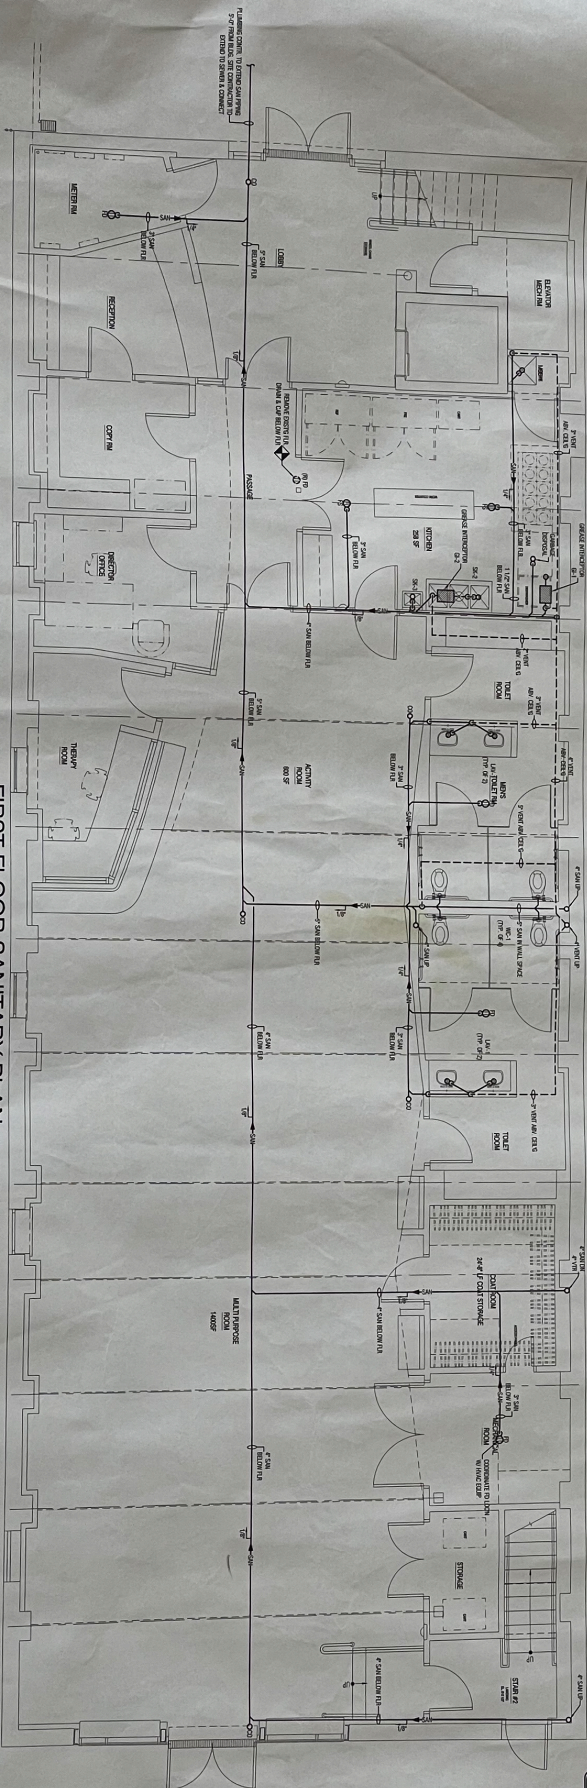

FIRST FLOOR SANITARY PLAN
SCALE: 1/4" = 1'-0"

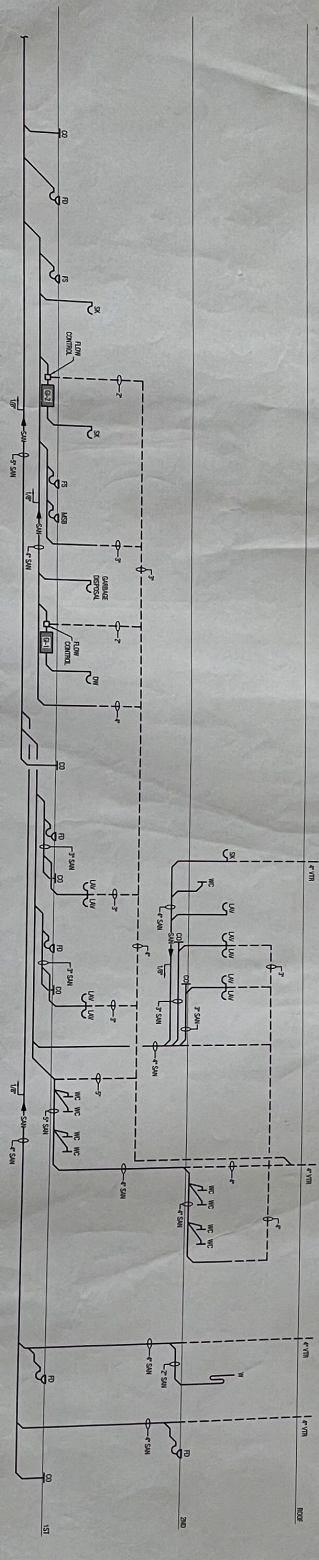

ELEVATOR PLUMBING NOTE
1. Location to provide the elevator shaft and the shaft door.
2. Location to provide the elevator shaft and the shaft door.
3. Location to provide the elevator shaft and the shaft door.

GENERAL PLUMBING NOTE
1. Standard system concepts shall be accounted for in the design.
2. Standard system concepts shall be accounted for in the design.